

AT&T WIRELESS, INC.
ATTENTION: PROJECT MANAGER
ROCKFORD, IL 61111

nsoro
A WIRELESS SOLUTIONS COMPANY

National Wireless Ventures, LLC

forge

FORGE SERVICES, INC.
T: (815) 244-4444
F: (815) 244-4444
2310 MONROE AVE., STE. 1119
OAK BROOK, IL 60153

kamry

KAMRY GROUP, INC.
PROJECT #423456
T: (815) 244-4444
F: (815) 244-4444
2310 MONROE AVE., STE. 1119
OAK BROOK, IL 60153

FORGE PROJECT NO. 6237

DRAWN BY: TL

CHECKED BY: FB

CONSTRUCT ONLY FROM DRAWINGS MARKED "ISSUED FOR CONSTRUCTION"

DRAFT

DATE SIGNED: _____

BY: _____

FORGE SERVICES, INC. ALL RIGHTS RESERVED


IL0821
CICERO

3908 S LARAMIE AVE
STICKNEY, IL 60804

WATER TOWER

SITE PLAN

C1.1

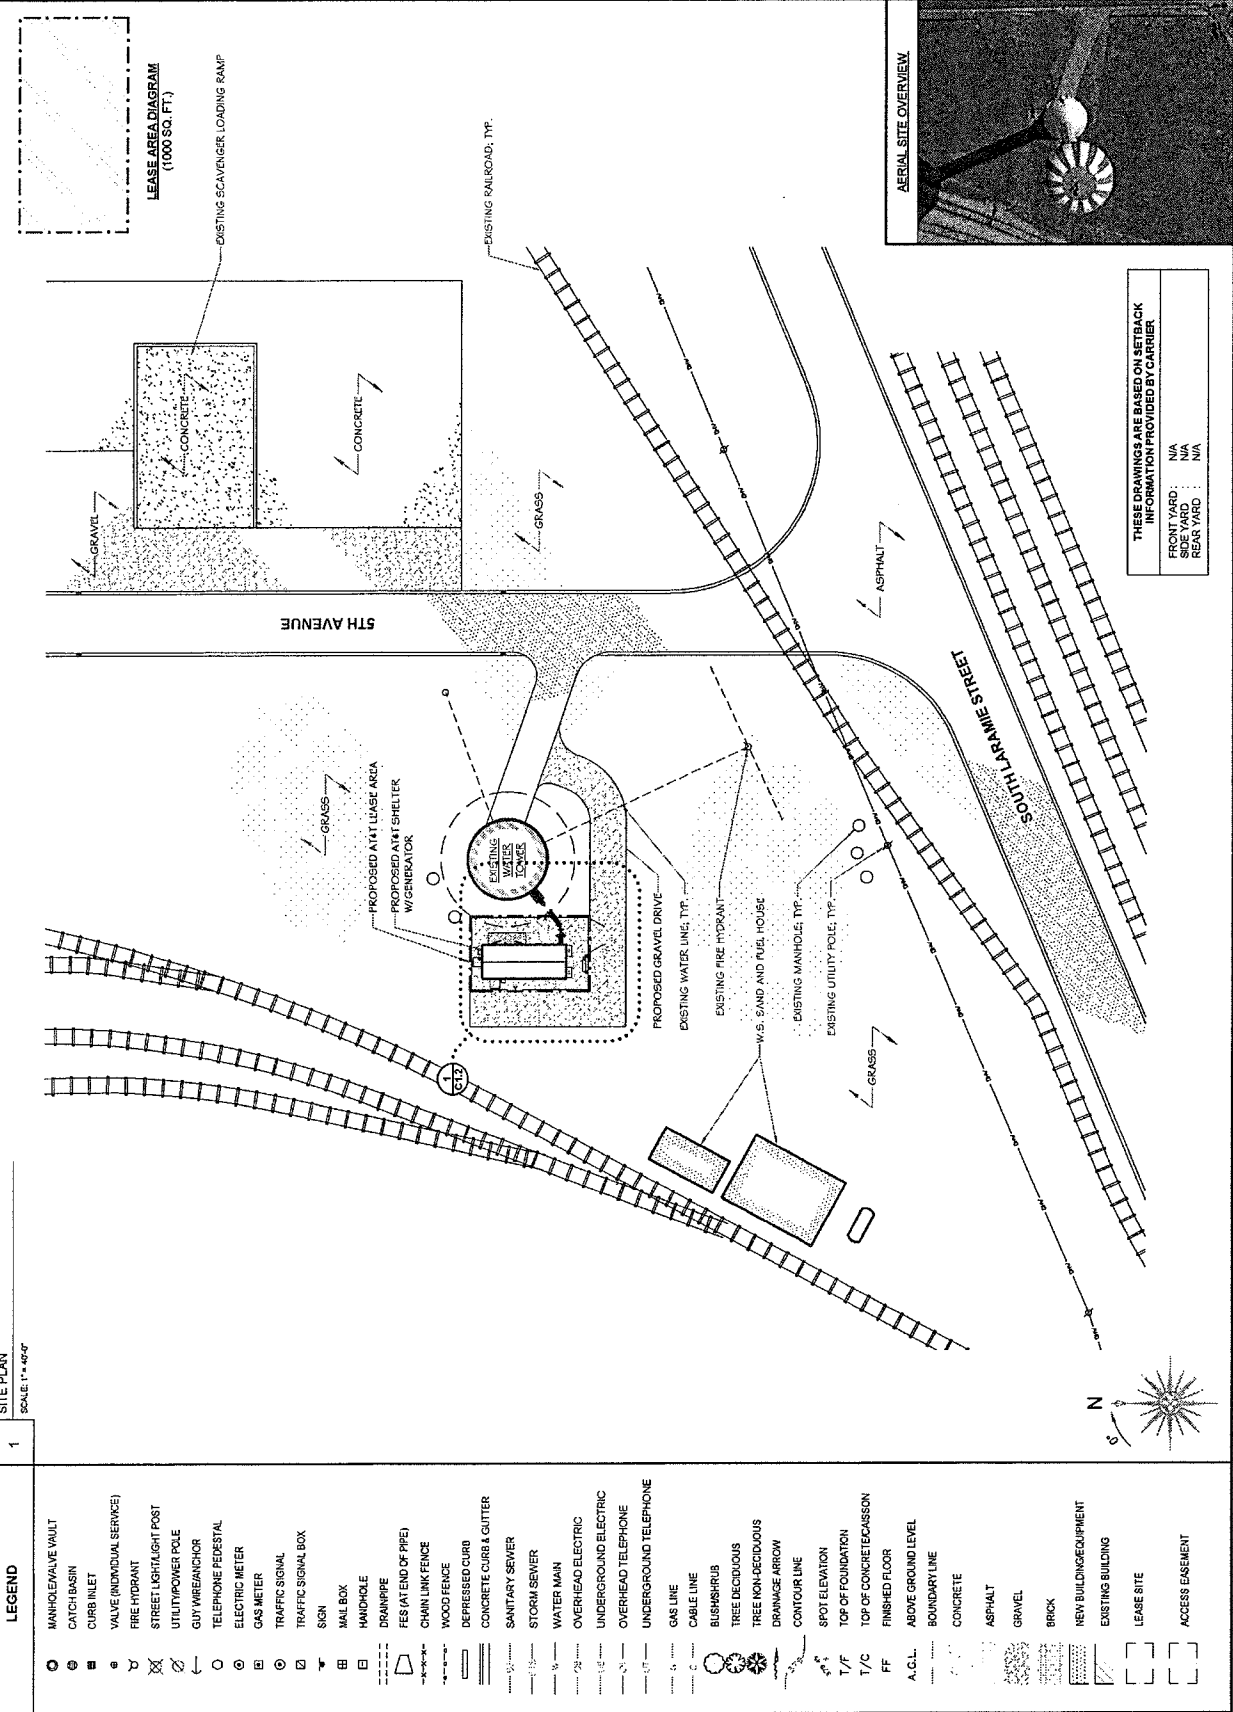

THESE DRAWINGS ARE BASED ON SETBACK INFORMATION PROVIDED BY CARRIER